
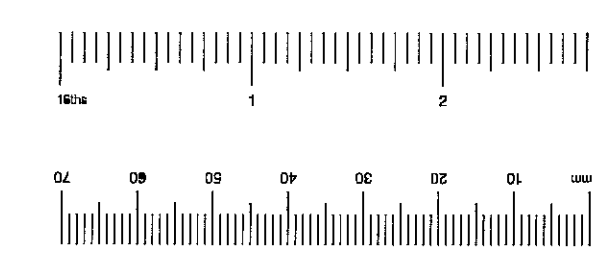


100mm on original sheet

no	description	date	initial	check
A	Initial Issue	Dec 01	CMF	
B	Services installation redesigned	Jan 01	CMF	

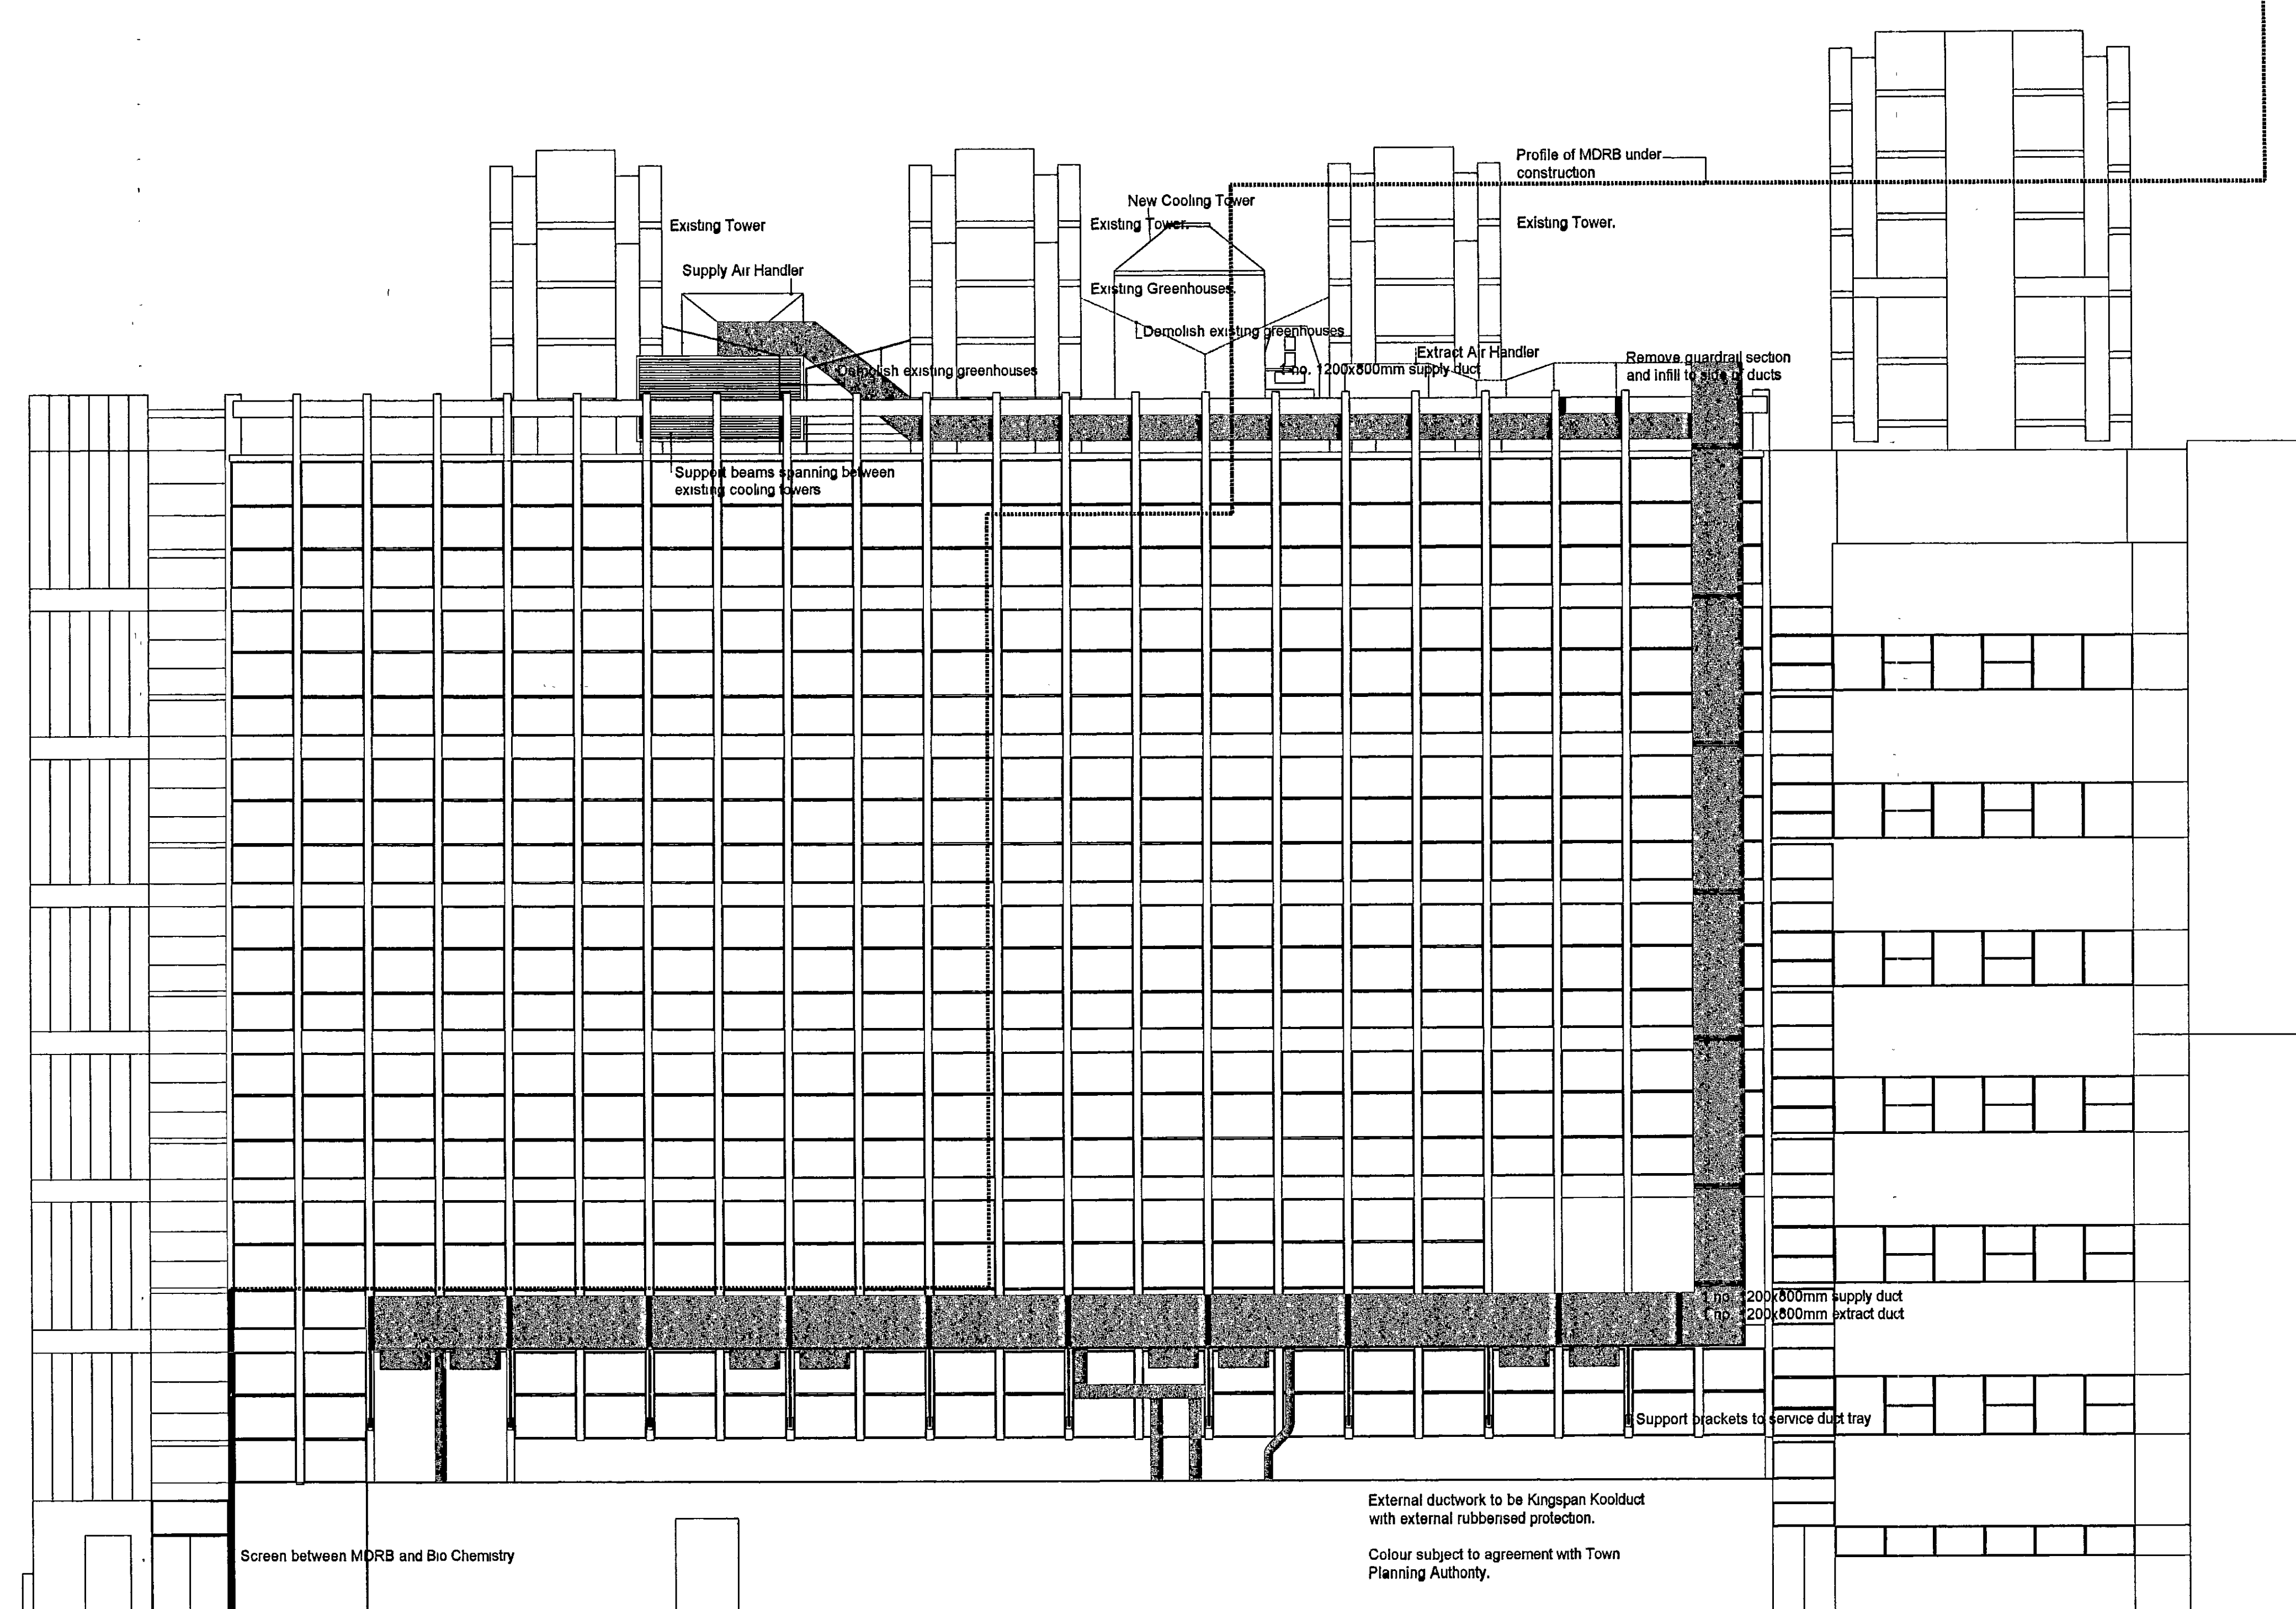

NOTE  
DO NOT SCALE FROM THIS DRAWING  
THIS DRAWING IS SUBJECT TO THE COPYRIGHT ACT

R.B.K. & C.  
TOWN PLANNING  
18 JAN 2001  
RECEIVED

**ACP**

Architects' Co-Partnership  
Northway House, Coopers Lane, Northway, Hertfordshire EN6 4PS  
Telephone 01707 651141 Fax 01707 652600  
Email ACParchitects@compuserve.com

client  
**IMPERIAL COLLEGE OF SCIENCE  
TECHNOLOGY & MEDICINE**

project  
INFRASTRUCTURE WORKS  
TEMPORARY SERVICES INSTALLATION

drawing  
PROPOSED SOUTH ELEVATION

scale	date drawn	drawn by	
1:100	08-12-2000	CMF	
1 check date	checked by	2 check date	checked by
	KM		

drawing no	revision
3407 (0) 009	B




169 QUEEN'S GATE

ARMSTRONG ROAD

BIOCHEMISTRY BUILDING

LINK BLOCK CHEMISTRY

REVISIONS				
no	description	date	initial	check

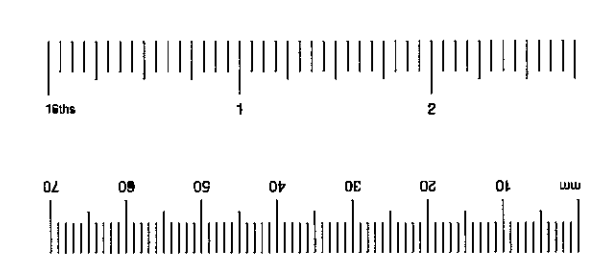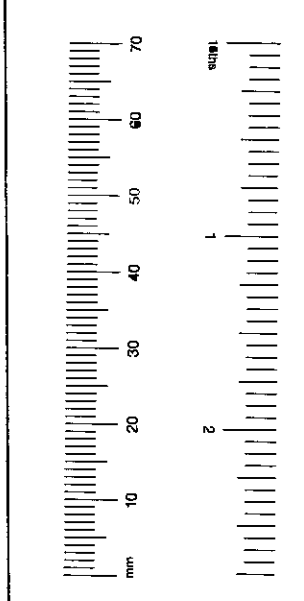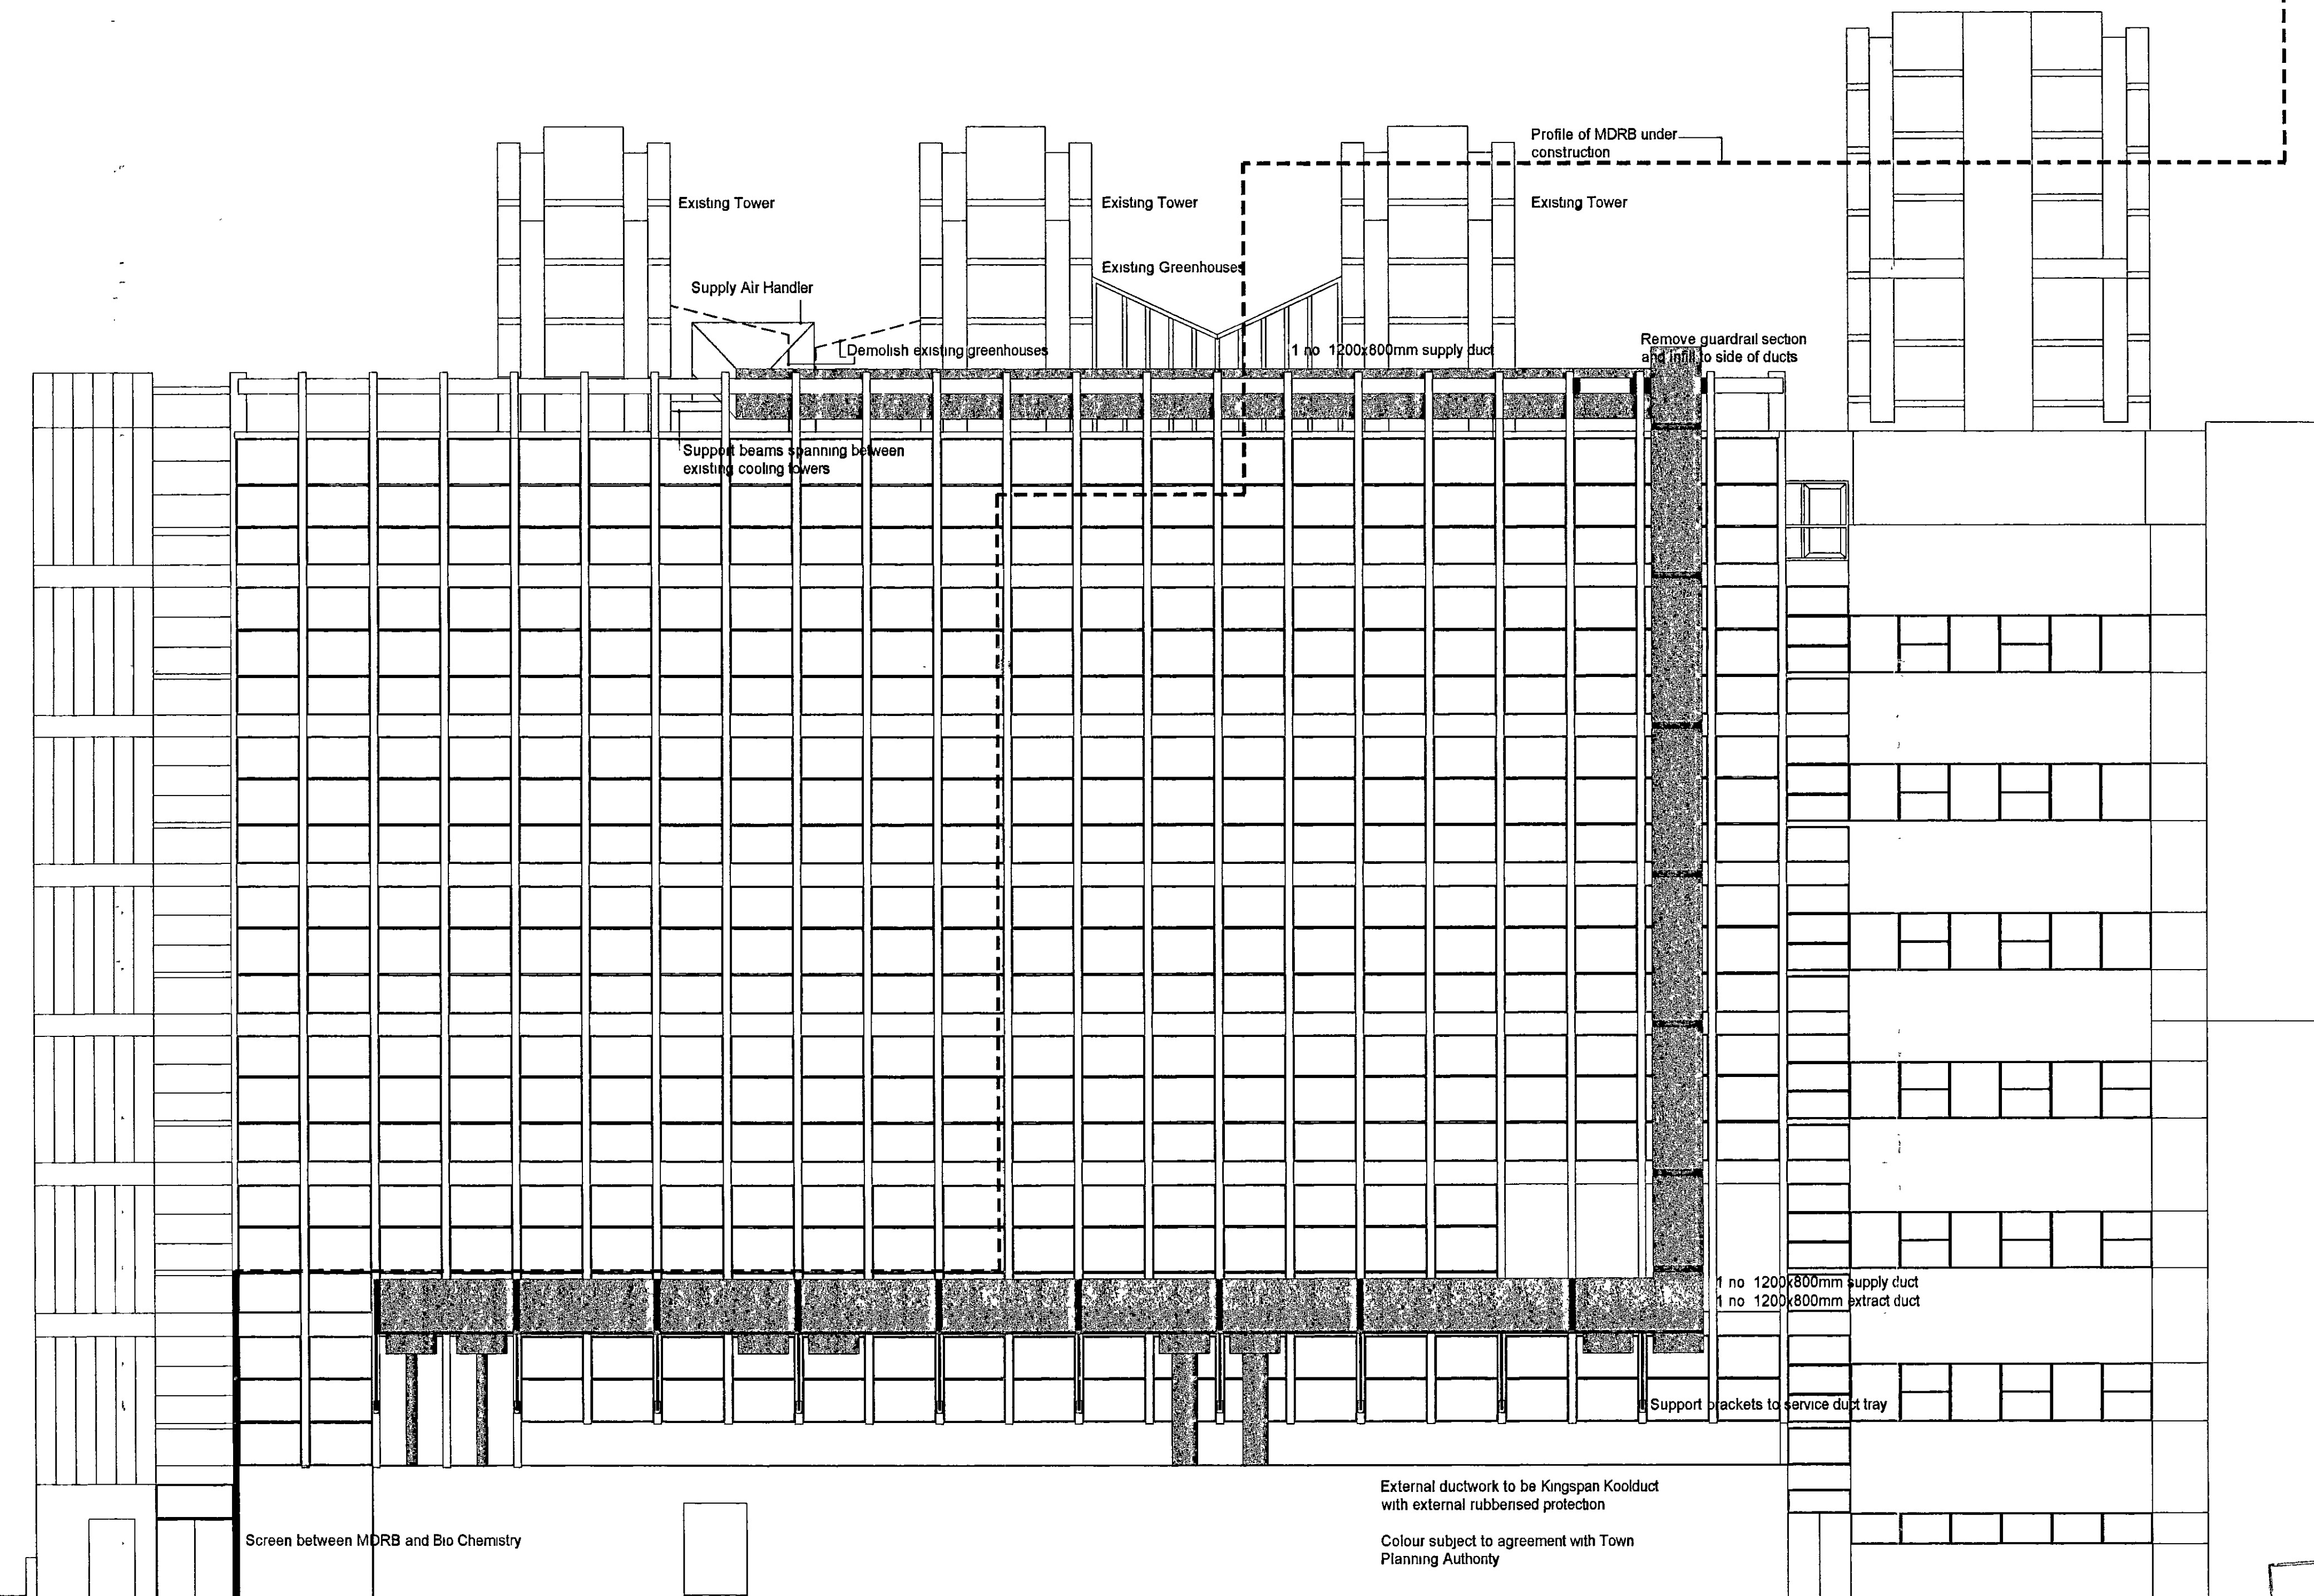

PROJ 002915  
R.B.K. & C.  
TOWN PLANNING  
20 DEC 2000  
RECEIVED

**ACP**  
Architects' Co-Partnership  
Northaw House, Coopers Lane, Northaw, Hertfordshire EN6 4PS  
Telephone: 01707 851141 Fax: 01707 852600  
Email: ACP@architects@compuserve.com

client  
**IMPERIAL COLLEGE OF SCIENCE  
TECHNOLOGY & MEDICINE**

project  
INFRASTRUCTURE WORKS  
TEMPORARY SERVICES INSTALLATION

drawing no  
3407 (0) 009  
PROPOSED SOUTH ELEVATION

scale 1:100	date drawn 08-12-2000	drawn by CMF
1 check date 10M	checked by	2 check date checked by
drawing no 3407 (0) 009	revision A	


169 QUEEN'S GATE

ARMSTRONG ROAD

BIOCHEMISTRY BUILDING

LINK BLOCK CHEMISTRY

revisions				
no	description	date	initial	check
A	Initial Issue	Dec 01	CMF	
B	Services Installation redesigned	Jan 01	CMF	

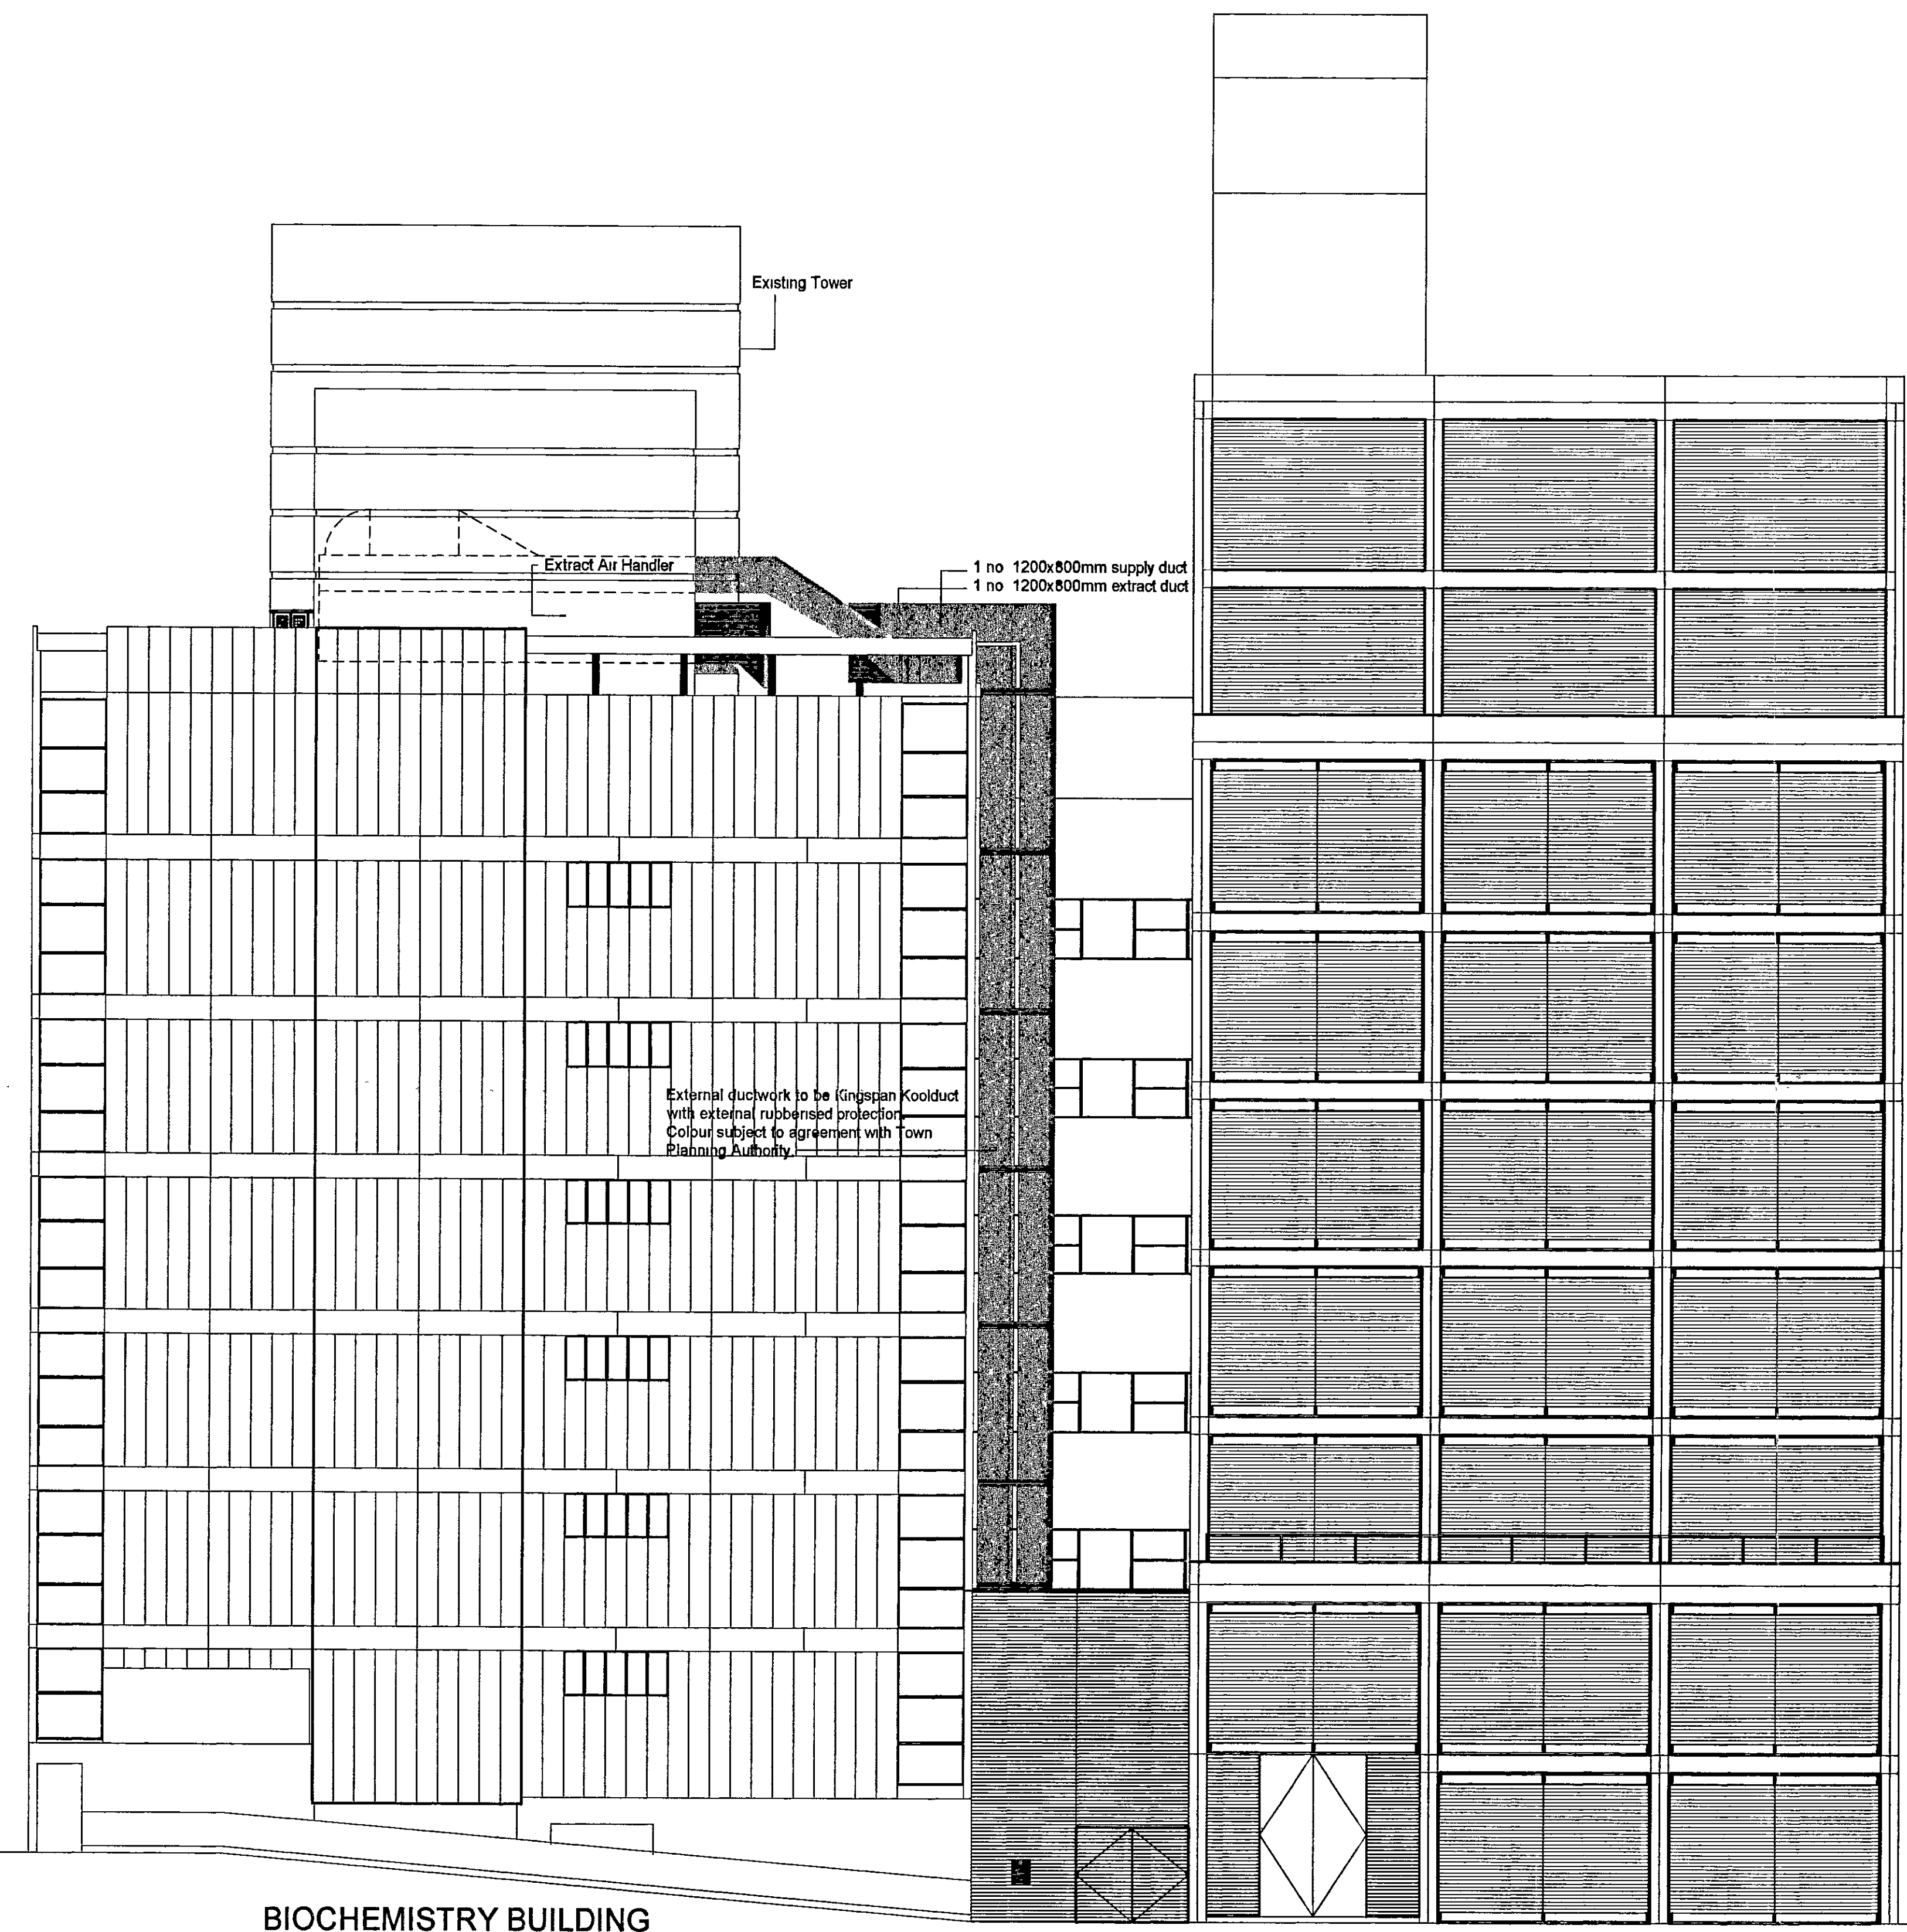

DELEGATED APPROVAL  
24 APR 2001

R.B.K. & C.  
TOWN PLANNING  
18 JAN 2001  
RECEIVED

**ACP**

Architects' Co-Partnership  
Northaw House, Coopers Lane, Northaw, Hertfordshire EN8 4PS  
Telephone 01707 651141 Fax 01707 652800  
Email ACParchitects@compuserve.com

client  
**IMPERIAL COLLEGE OF SCIENCE  
TECHNOLOGY & MEDICINE**

project  
**INFRASTRUCTURE WORKS  
TEMPORARY SERVICES INSTALLATION**

drawing  
**PROPOSED WEST ELEVATION**

scale 1:100	date drawn 08-12-2000	drawn by CMF
1 check date	checked by JM	2 check date
checked by		checked by
drawing no 3407 (0) 010		revision B


LIBRARY

IMPERIAL COLLEGE ROAD

BIOCHEMISTRY BUILDING

MDR BUILDING (UNDER CONSTRUCTION)


Science Museum  
Wellcome Wing

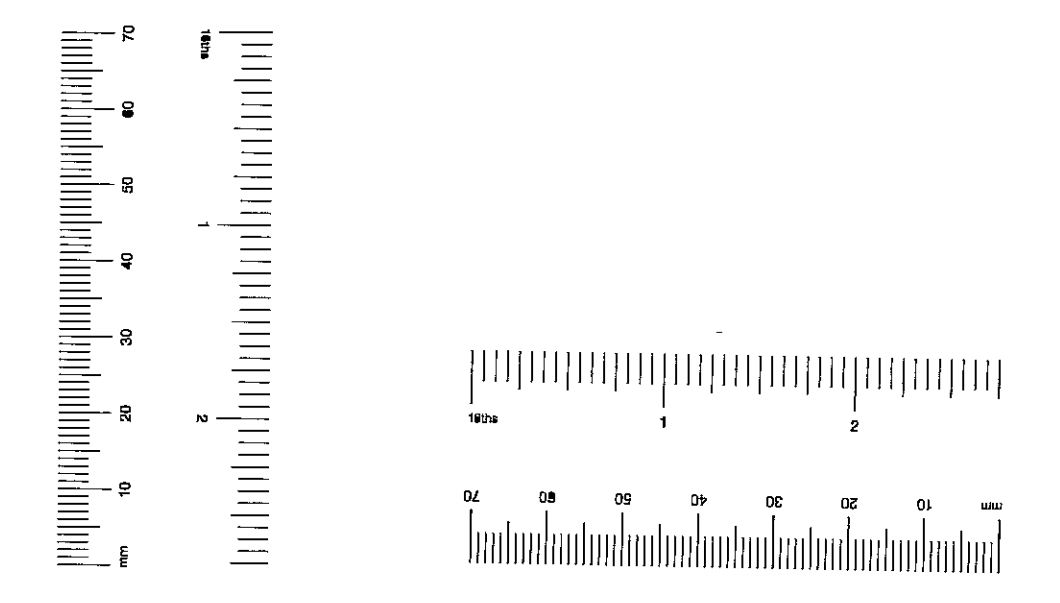



100mm on original sheet

revisions				
no	description	date	initial	check
A	Initial Issue	Dec 01	CMF	
B	Services Installation redesigned	Jan 01	CMF	

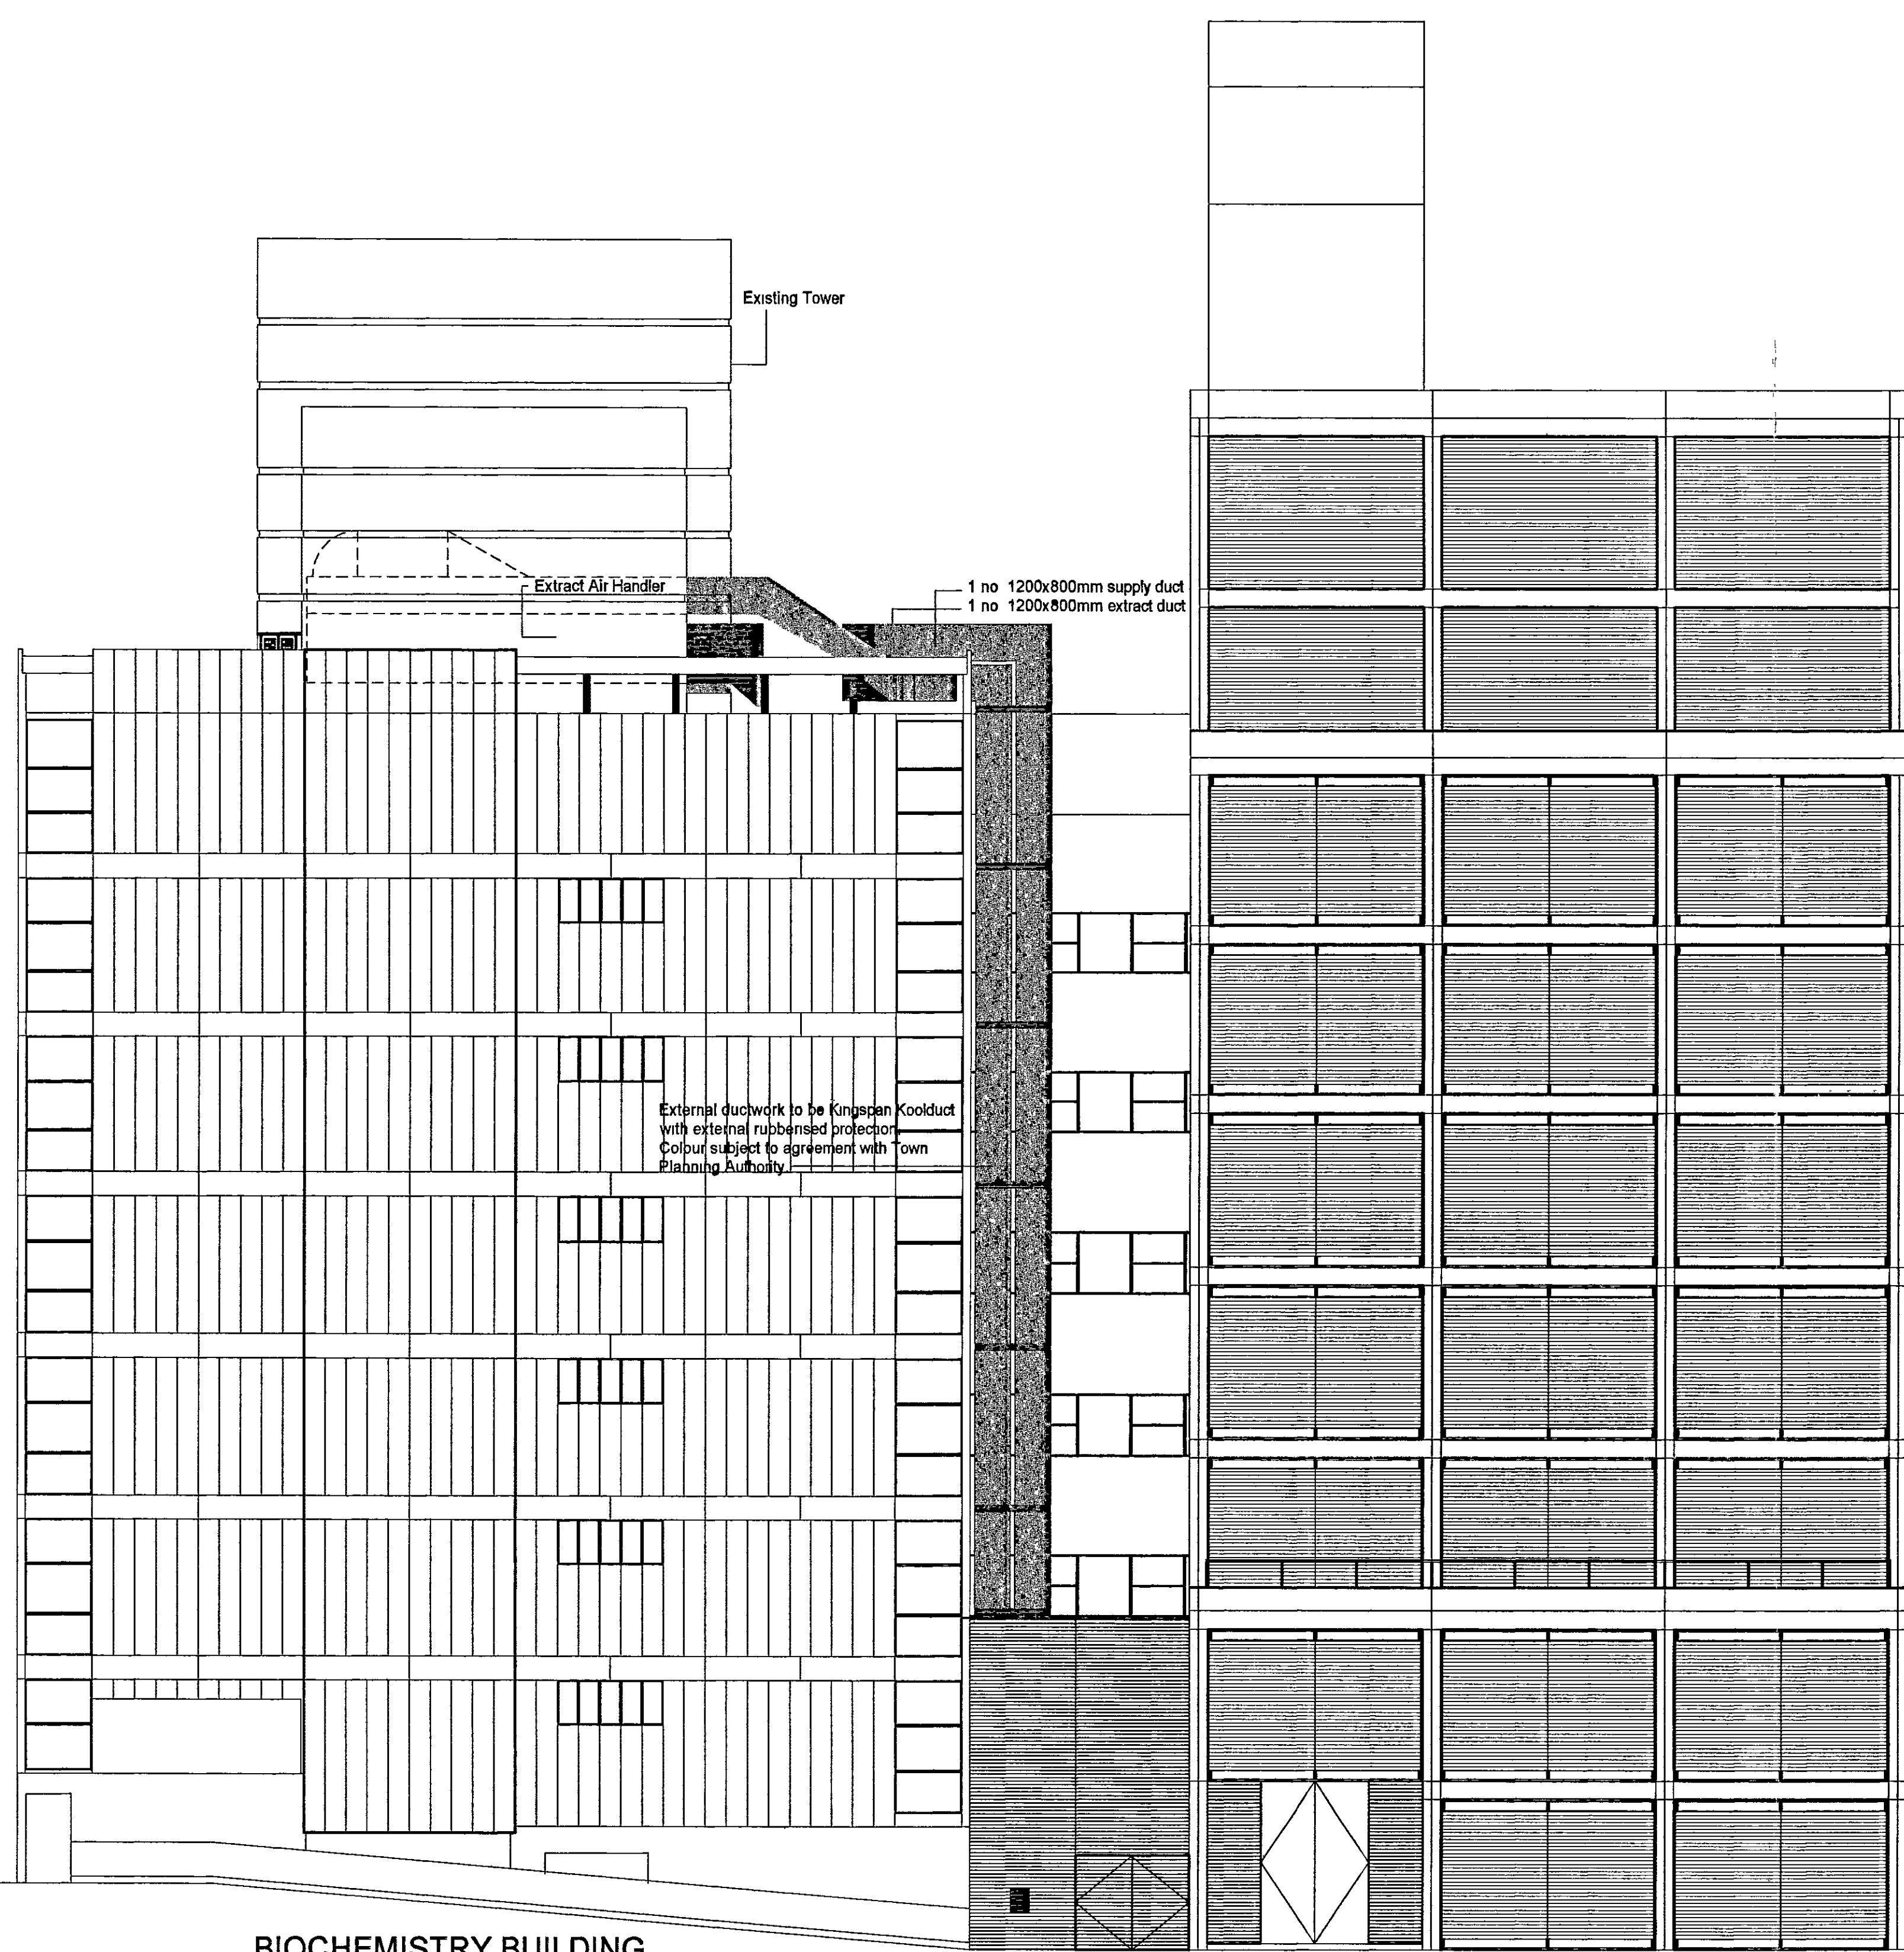

NOTE:  
DO NOT SCALE FROM THIS DRAWING  
THIS DRAWING IS SUBJECT TO THE COPYRIGHT ACT

R.B.K. & C.  
TOWN PLANNING  
18 JAN 2001  
RECEIVED

**ACP**

Architects' Co-Partnership  
Northaw House, Coopers Lane, Northaw, Hertfordshire EN6 4PS  
Telephone: 01707 851141 Fax: 01707 652800  
Email: ACPArchitects@compuserve.com

client  
**IMPERIAL COLLEGE OF SCIENCE  
TECHNOLOGY & MEDICINE**

project  
INFRASTRUCTURE WORKS  
TEMPORARY SERVICES INSTALLATION


drawing  
**PROPOSED WEST ELEVATION**

scale  
1:100


date drawn 06-12-2000	drawn by CMF
1 check date NM	checked by
2 check date	checked by

drawing no 3407 (0) 010	revision B
----------------------------	---------------

LIBRARY      IMPERIAL COLLEGE ROAD      BIOCHEMISTRY BUILDING      MDR BUILDING (UNDER CONSTRUCTION)      Science Museum Wellcome Wing

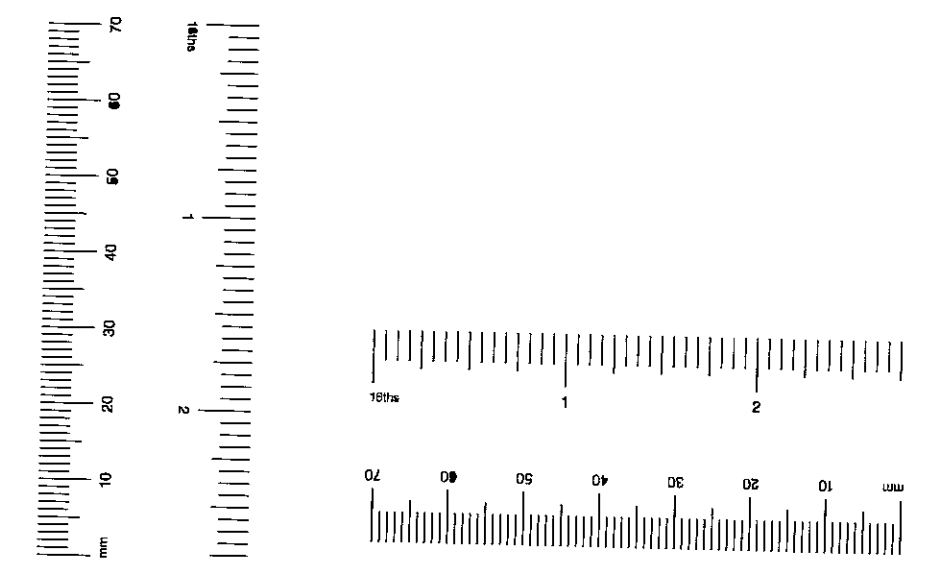

revisions				
no	description	date	initial	check
A	Initial Issue	Dec 01	CMF	
B	Services Installation redesigned	Jan 01	CMF	

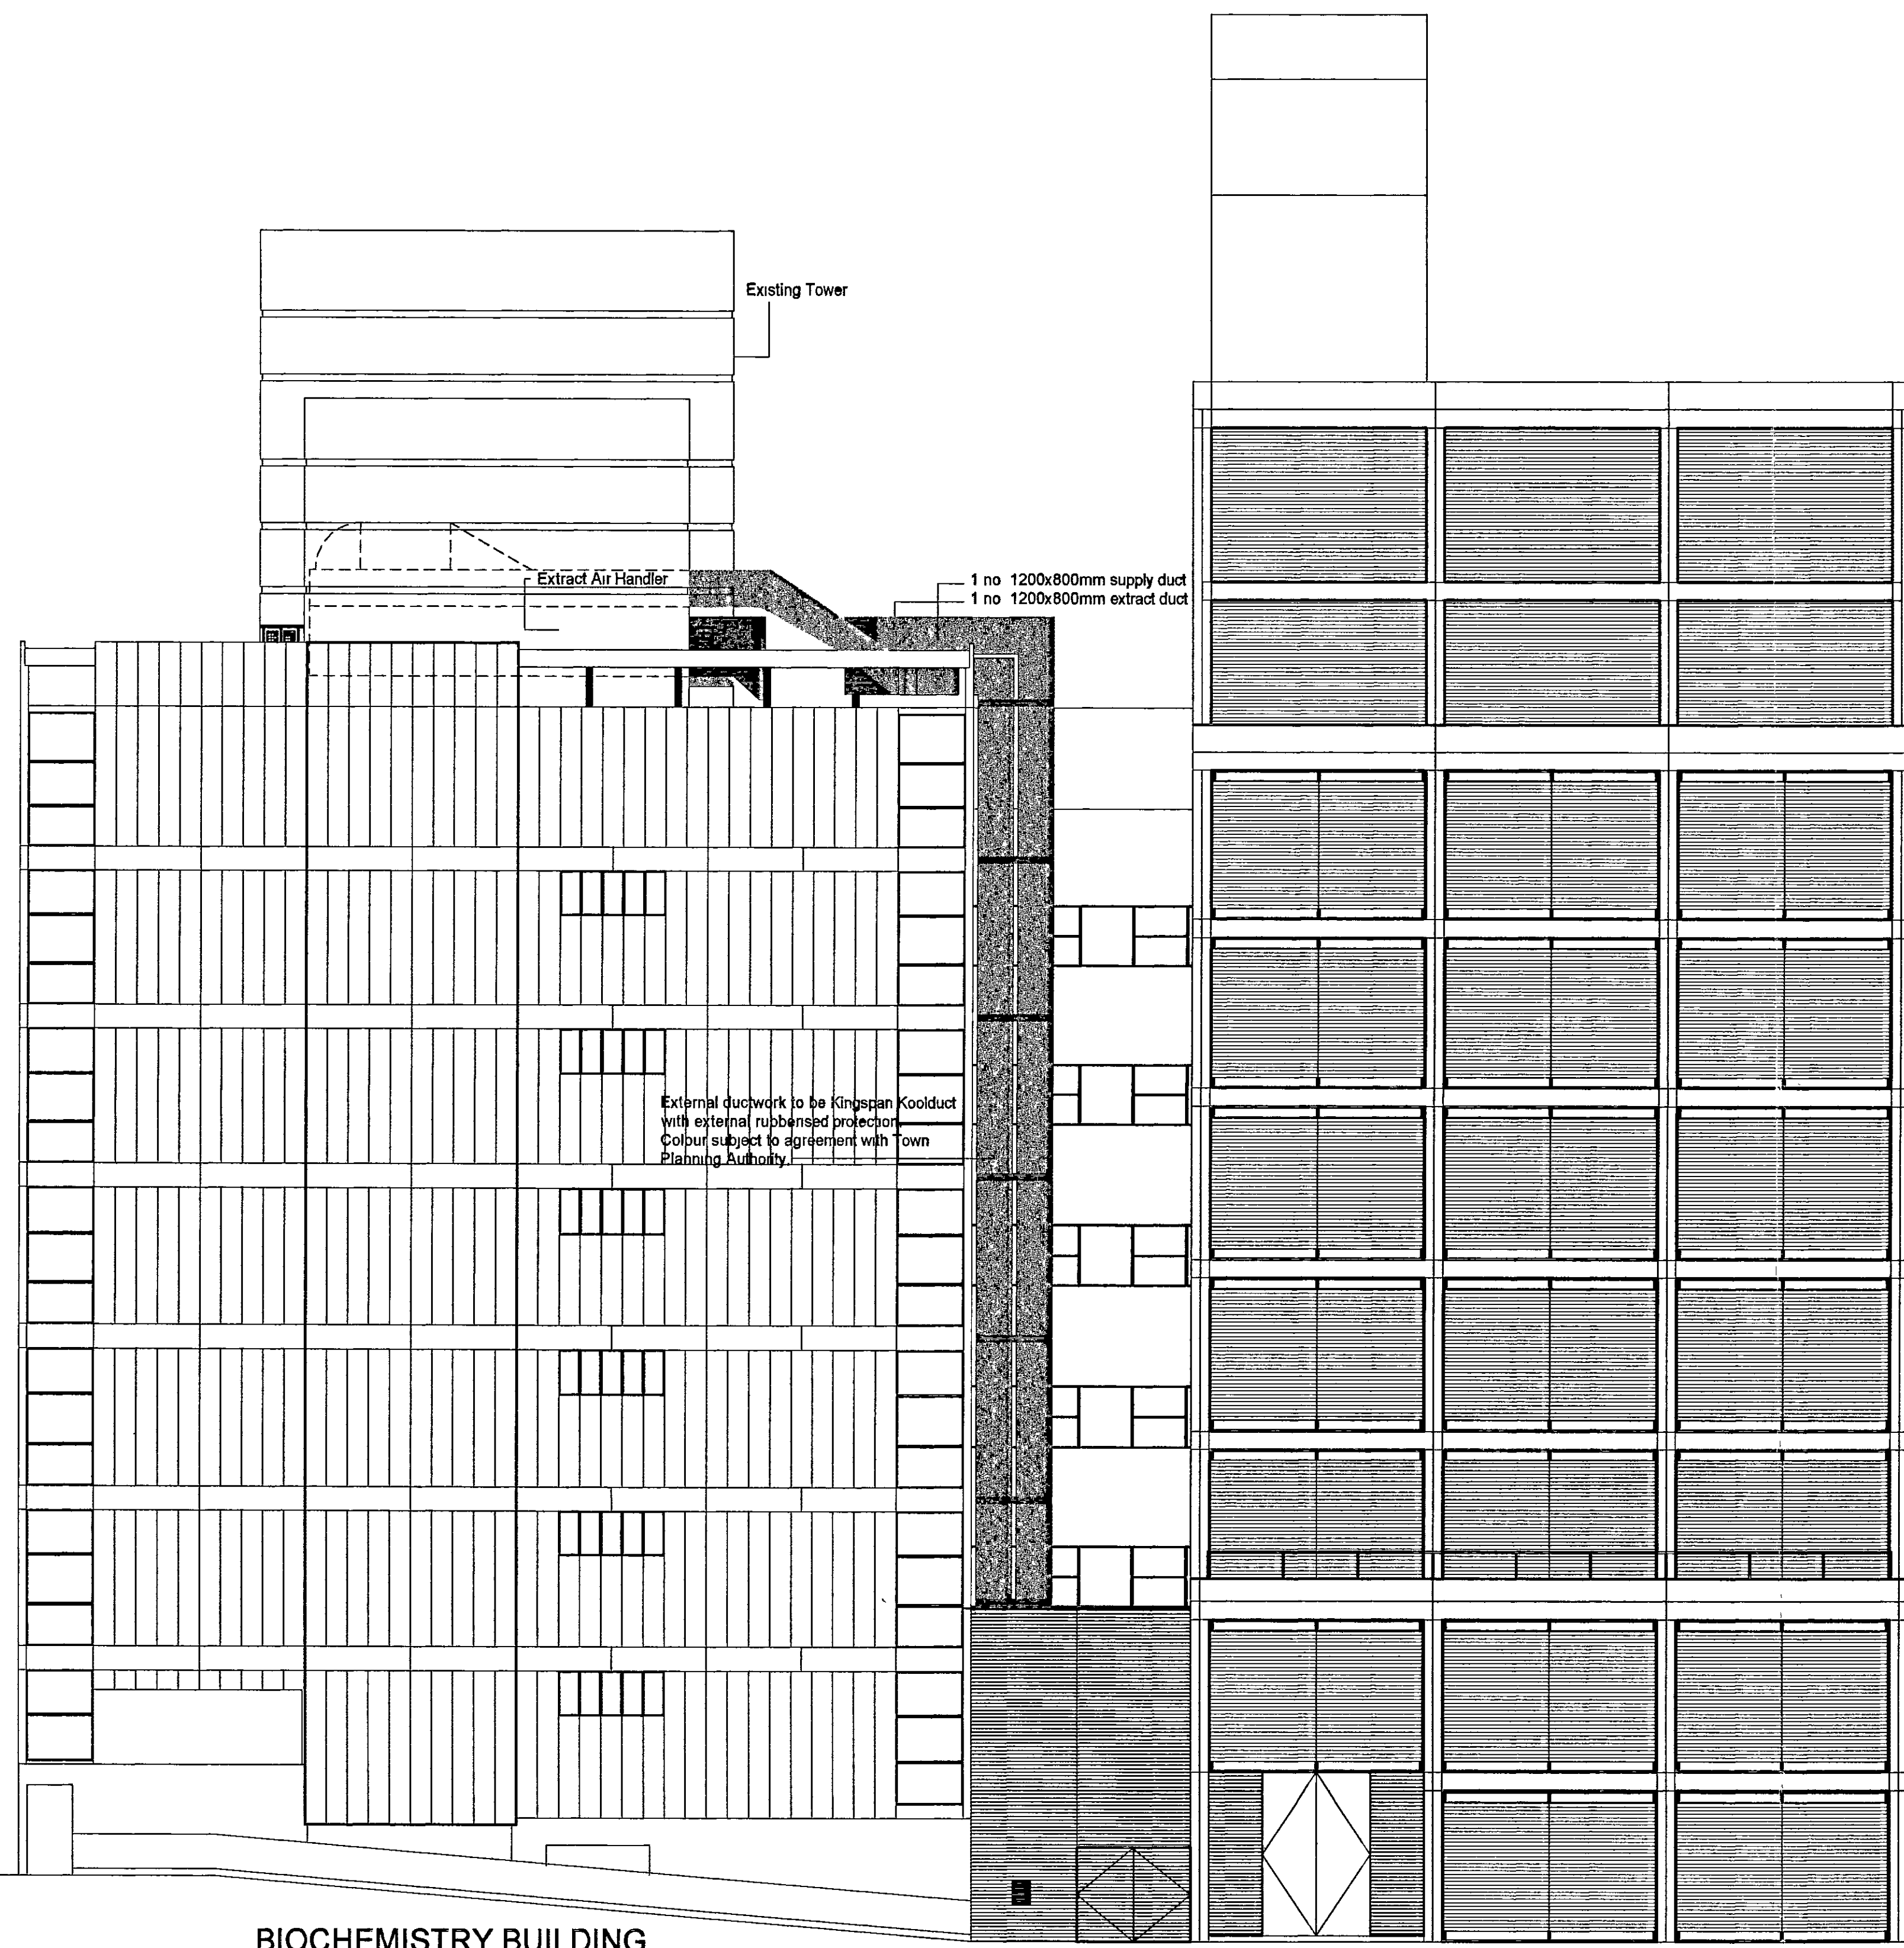

DO NOT SCALE FROM THIS DRAWING  
THIS DRAWING IS SUBJECT TO THE COPYRIGHT ACT

R.B.K. & C.  
TOWN PLANNING  
18 JAN 2001  
RECEIVED

**ACP**

Architects' Co-Partnership  
Northway House, Coopers Lane, Northway, Hertfordshire EN8 4PS  
Telephone 01707 851441 Fax 01707 852800  
Email ACPArchitects@compuserve.com

client  
**IMPERIAL COLLEGE OF SCIENCE  
TECHNOLOGY & MEDICINE**

project  
INFRASTRUCTURE WORKS  
TEMPORARY SERVICES INSTALLATION

drawing  
PROPOSED WEST ELEVATION

scale 1:100	date drawn 08-12-2000	drawn by CMF
1 check date 10M	checked by	2 check date checked by
drawing no 3407 (0) 010	revision B	

LIBRARY



IMPERIAL COLLEGE ROAD

BIOCHEMISTRY BUILDING


MDR BUILDING (UNDER CONSTRUCTION)

Science Museum  
Wellcome Wing

ARMSTRONG ROAD

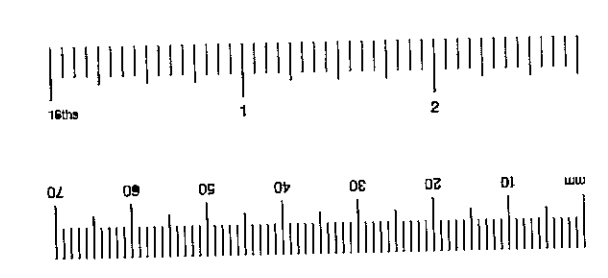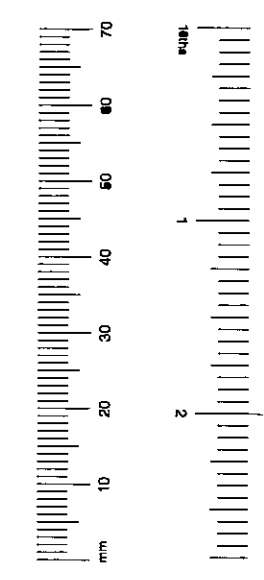

revisions			
no	description	date	check

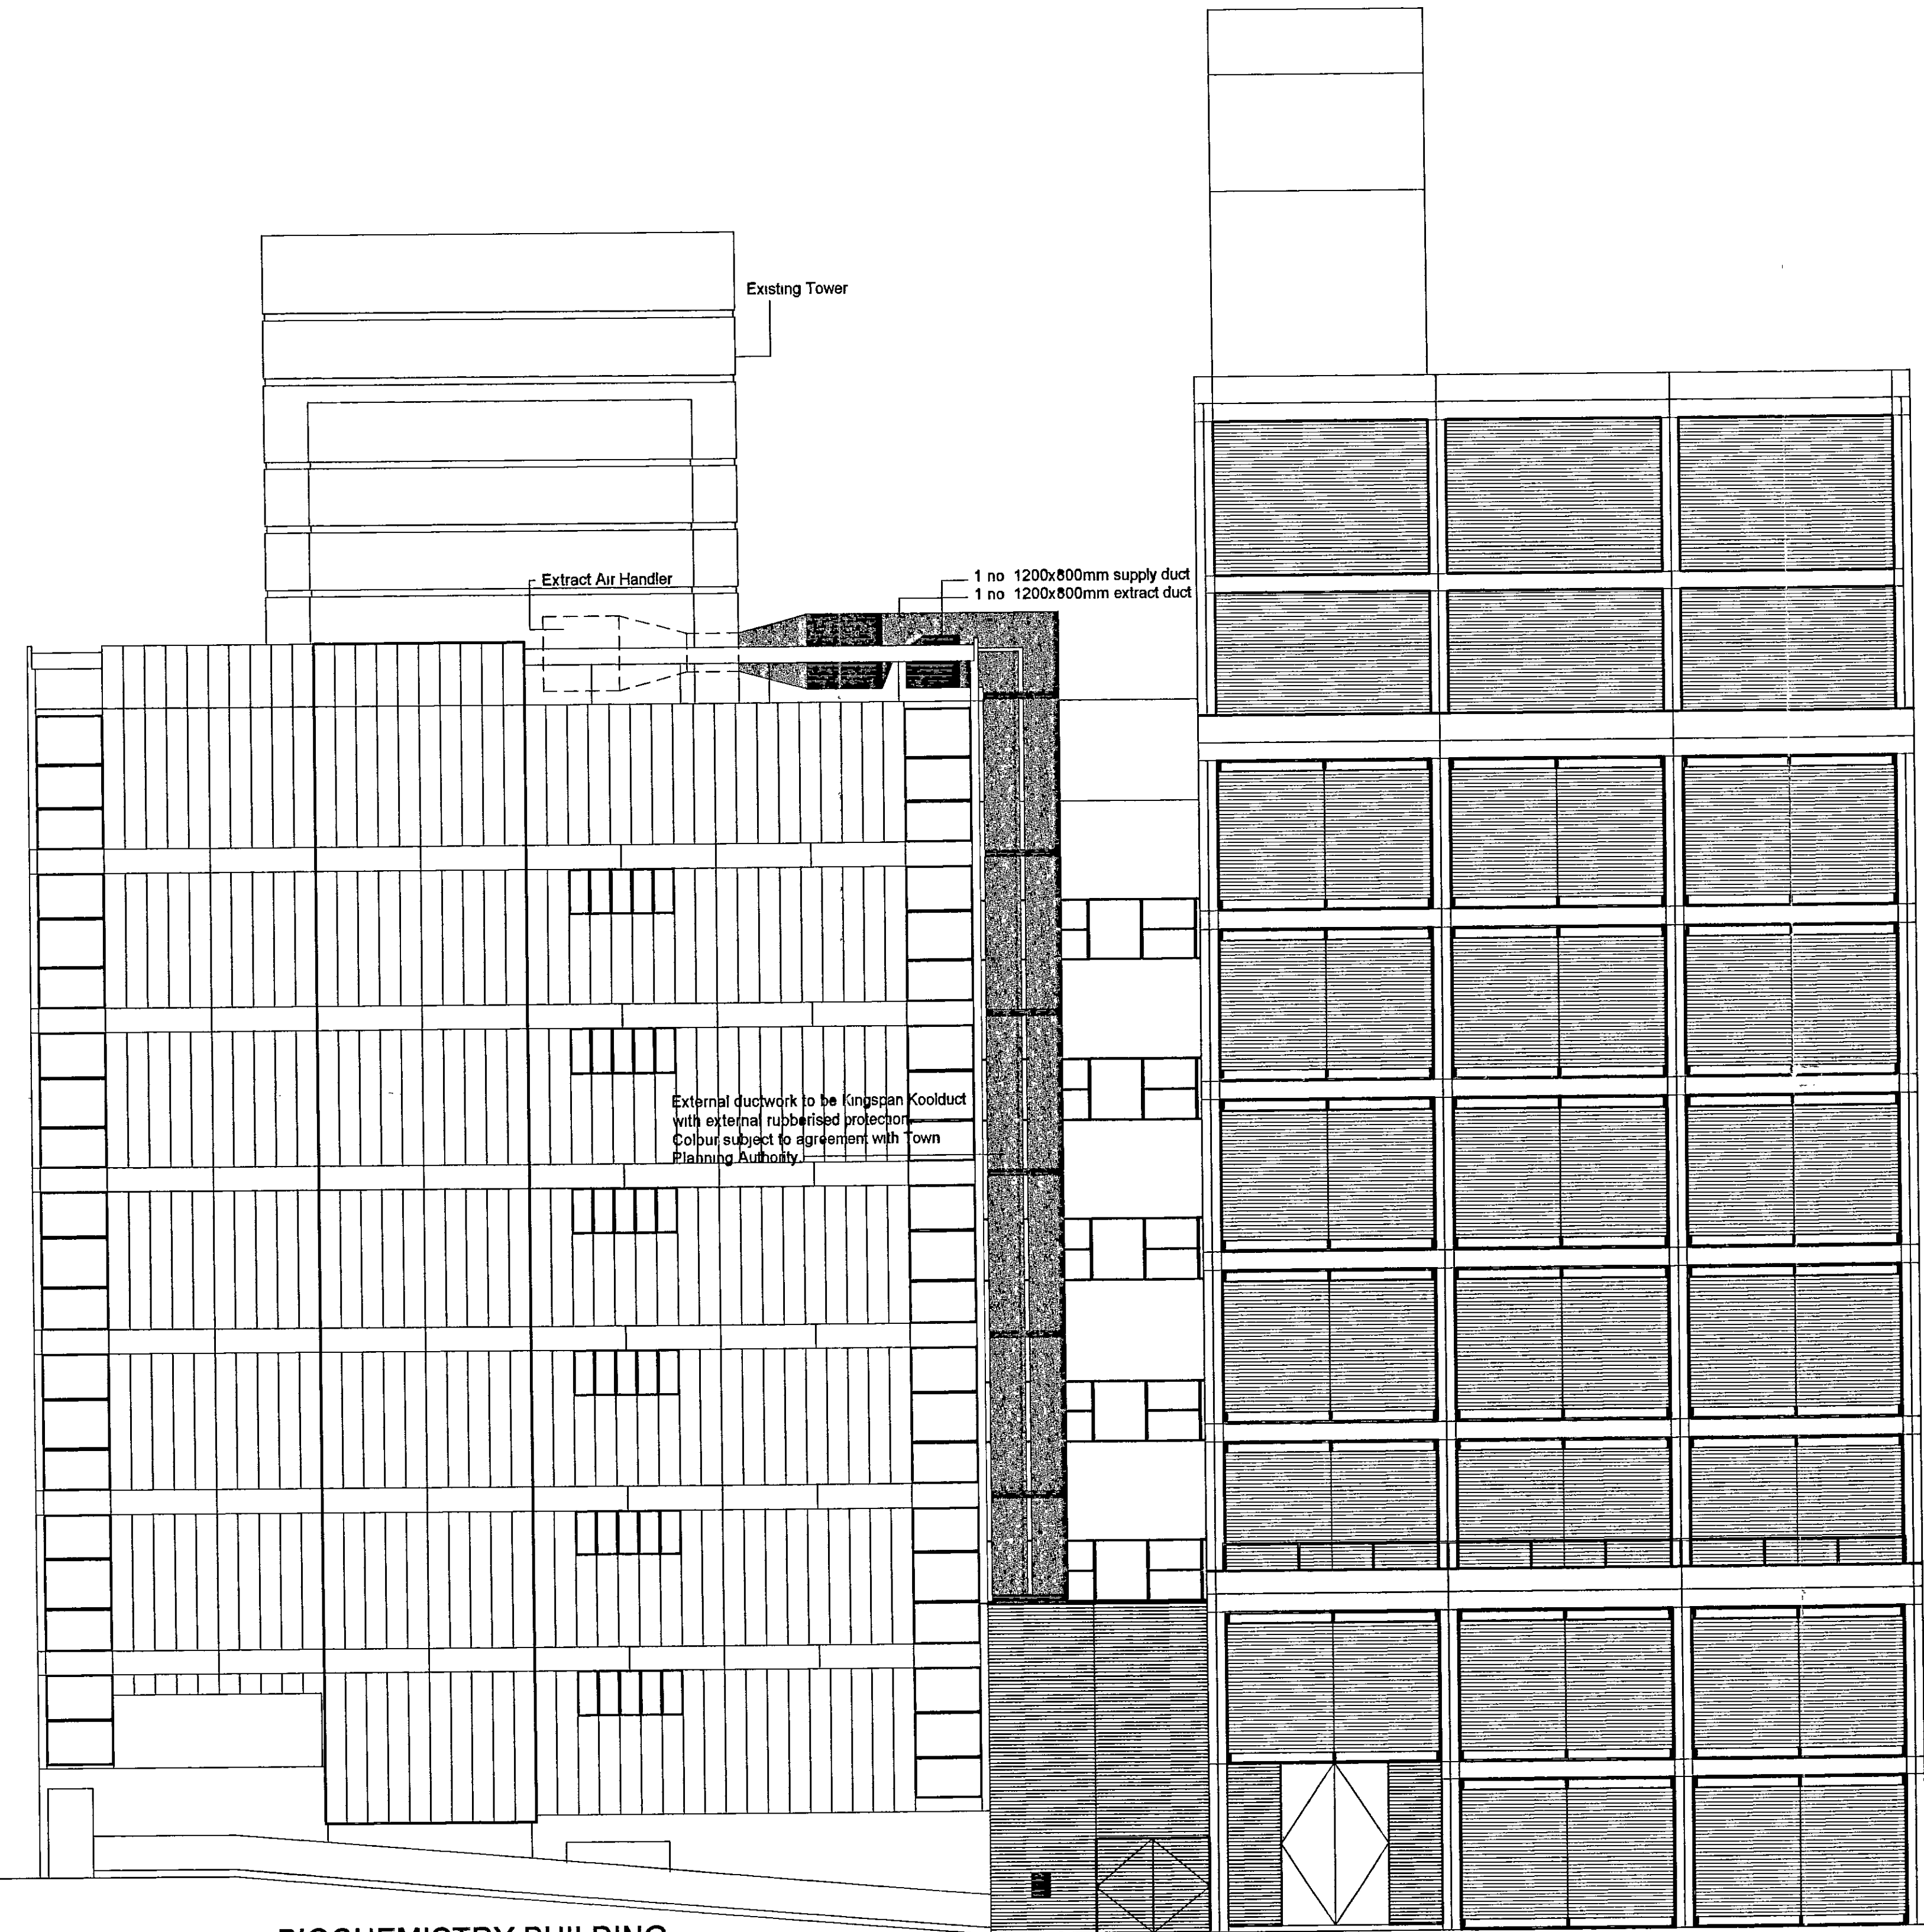

External ductwork to be kinspan Koolduct with external rubberised protection. Colour subject to agreement with Town Planning Authority.

DO NOT SCALE FROM THIS DRAWING THIS DRAWING IS SUBJECT TO THE COPYRIGHT ACT

PFC02915  
**R.B.K. & C.**  
**TOWN PLANNING**  
 20 DEC 2000  
**RECEIVED**

**ACP**

Architects' Co-Partnership  
 Northaw House, Coopers Lane, Northaw, Hertfordshire EN8 4PS  
 Telephone 01707 651141 Fax 01707 652600  
 Email ACPArchitects@compuserve.com

client  
**IMPERIAL COLLEGE OF SCIENCE  
 TECHNOLOGY & MEDICINE**

project  
**INFRASTRUCTURE WORKS  
 TEMPORARY SERVICES INSTALLATION**

drawing  
**SUPERSEDED**  
**PROPOSED WEST ELEVATION**

scale 1:100	date drawn 08-10-2000	drawn by CMF
1 check date	checked by JRM	2 check date
checked by	checked by	checked by
drawing no 3407 (0) 010	revision A	

ARMSTRONG ROAD

LIBRARY

IMPERIAL COLLEGE ROAD

BIOCHEMISTRY BUILDING

MDR BUILDING (UNDER CONSTRUCTION)

Science Museum  
Wellcome Wing

